



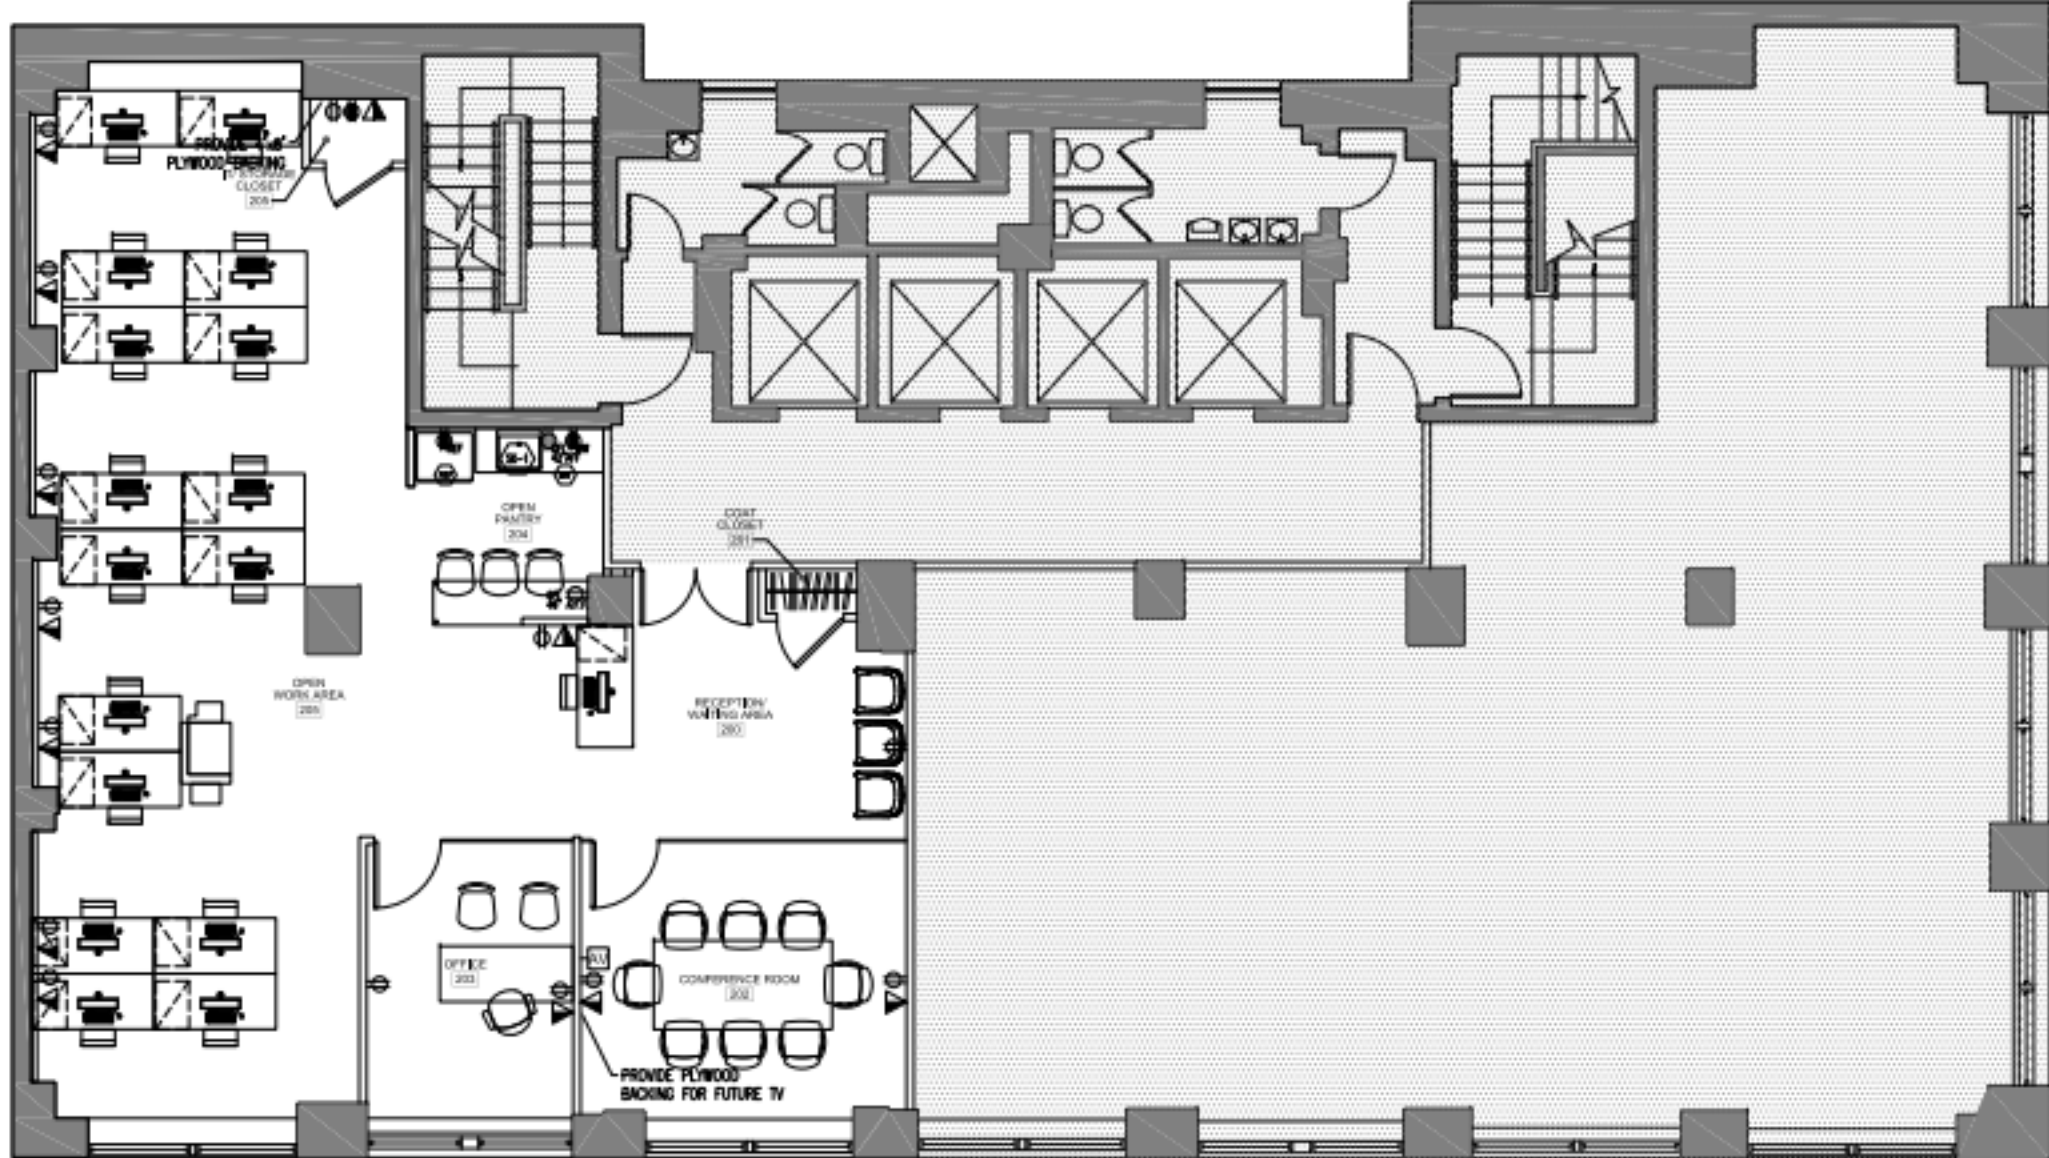

PARTIAL 2ND FLOOR POWER AND DATA PLAN (SCALE: 1/4" = 1'-0") 1

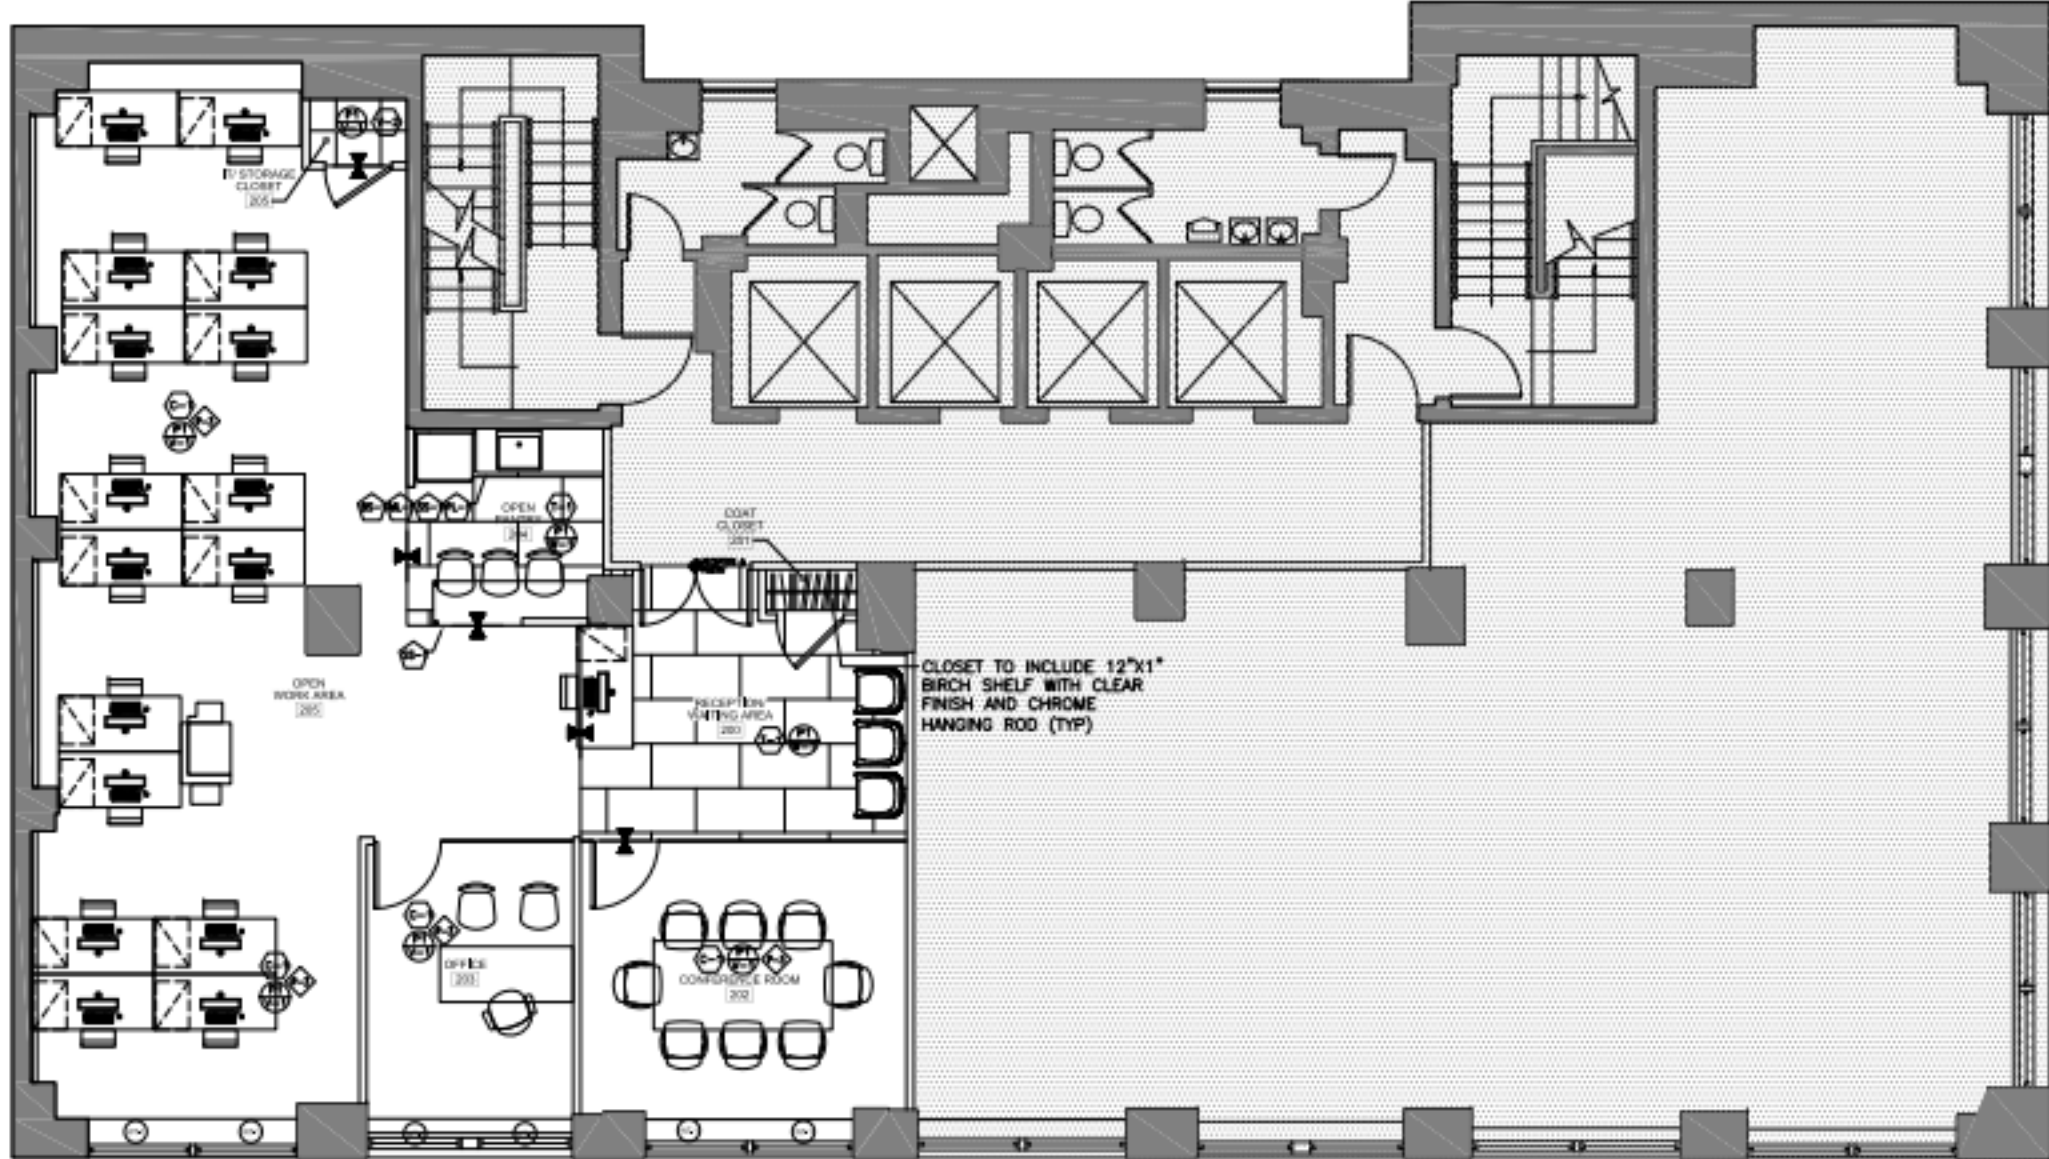

PARTIAL 2ND FLOOR FINISH PLAN (SCALE: 1/4" = 1'-0") 2


LEGEND

- QUAD OUTLET
- DUPLEX OUTLET
- GROUND FAULT INTERRUPT OUTLET (TYPICAL @ ALL WET LOCATIONS)
- DEDICATED OUTLET
- VOICE/DATA- PROVIDE BACK BOX AND 3/4" CONDUIT W/ PULL STRING TO ACCESSIBLE CEILING LOCATION
- DATA LINE- PROVIDE BACK BOX AND 3/4" CONDUIT W/ PULL STRING TO ACCESSIBLE CEILING LOCATION
- POTS/FAX LINE- PROVIDE BACK BOX AND 3/4" CONDUIT W/ PULL STRING TO ACCESSIBLE CEILING LOCATION
- AUDIO VISUAL CABLE CONNECTION- PROVIDE BACK BOX AND 2" CONDUIT W/ PULL STRING TO ACCESSIBLE CEILING. SEE PLAN FOR WIRING DIAGRAM
- RECESSED FLOOR POWER/DATA BOX. SEE PLAN FOR LOCATION PROVIDED:
 - 2" FOR HDMI AND VGA
 - 1 3/4" FOR DATA
 - 1 3/4" FOR POWER

APPLIANCE SCHEDULE

- REFRIGERATOR - SUMMIT 28 INCH MODEL: FT151225M FINISH: STAINLESS STEEL
- MICROWAVE - LG STUDIO MODEL: LSRM2010ST FINISH: STAINLESS STEEL REMARKS: GC TO COORDINATE WITH MILLWORK CONTRACTOR, INCLUDE 30" TRIM KIT (MCO330P)
- DISH WASHER - SUMMIT MODEL: DW2433SSADA FINISH: STAINLESS STEEL REMARKS: GC TO COORDINATE LOCATION FOR WATER LINE WITH TENANT
- COFFEE MAKER GC TO COORDINATE LOCATION FOR WATER LINE WITH TENANT

DEVICE MOUNTING HEIGHT

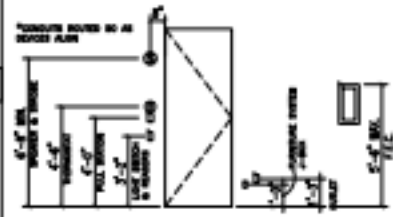

FLOOR FINISH TYPES:

- CARPET: PROVIDED BY TENANT REMARKS: INSTALLED BY G.C. (REVIEW LAYOUT WITH ARCHITECT)
- PORCELAIN TILE MANUFACTURER: STONEISLAND STYLE: G STONE COLOR: GREY - LAPPED REMARKS: CONFIRM LAYOUT WITH ARCHITECT
- VINYL TILE MANUFACTURER: WASHINGTON STYLE: SPICA - ABSTRACT COLOR: TWO TONES REMARKS: CONFIRM LAYOUT WITH ARCHITECT

BASE FINISH TYPES:

- BASE AT CARPET: JOHNSONITE COLOR: JOHNSONITE 280 SIZE: 4" TALL, 3" THICKNESS PROFILE: CHAMFER BASE (NO TONGUE)
- BASE AT VINYL: WOOD COLOR: JOHNSONITE 280 SIZE: 4" TALL, 3" THICKNESS PROFILE: RECTANGULAR REMARKS: PAINT TO MATCH ADJACENT WALL, SEMI-GLOSS FINISH

WALL FINISH TYPES:

- PAINT (JOHNSON): BENJAMIN MOORE COLOR: OC-17 DOVE WHITE FINISH: EGG SHELL (SEMI-GLOSS AT CORNER CONERS)

CEILING FINISH TYPES:

- PAINT: BENJAMIN MOORE COLOR: SUPER WHITE FW-1 FINISH: FLAT

WINDOW TREATMENT FINISHES:

- SOLAR SHADE: ROLLUP SERIES: ALUMINUM COLOR: ROLL UP BE WHITE INCLUDE: FASID AT WINDOWS WITH NO DROPPED CEILING

PANTRY FINISH TYPES:

- PLASTIC LAMINATE - CABINETS DOORS AND FACE MANUFACTURER: LAMTECH CHROMACORE COLOR: WHITE 3112 FINISH: GLOSSY
- MOSAIC TILE - BACK SPLASH MANUFACTURER: MEMO TILE PATTERN: HERRINGBONE COLOR: WHITE WHITE GROUT: MAPLE BROWN
- SOLID SURFACE - COUNTER TOP MANUFACTURER: CAESARSTONE COLLECTION: CLASSICS COLOR: 8131 CALACATA MARA
- MELAMINE - CABINET SHELVES AND INTERIORS COLOR: WHITE

12/18/17	ISSUED FOR 10
File	Date
Issue and Revision	

Rev. 10/17
100 Madison Avenue
NEW YORK, NY
BLOCK NO. 1274
LOT NO. 116
2014-01-01-01



PARTIAL 2ND FLOOR POWER AND DATA AND FINISH PLANS

Issue Date: 12/18/17
Project No.: 1001-01-01
Drawing No.: 101
Scale: AS SHOWN
Date: 12/18/17

A-102.00