


East 49th Street

SCISSOR STAIR
STAIR WELL A

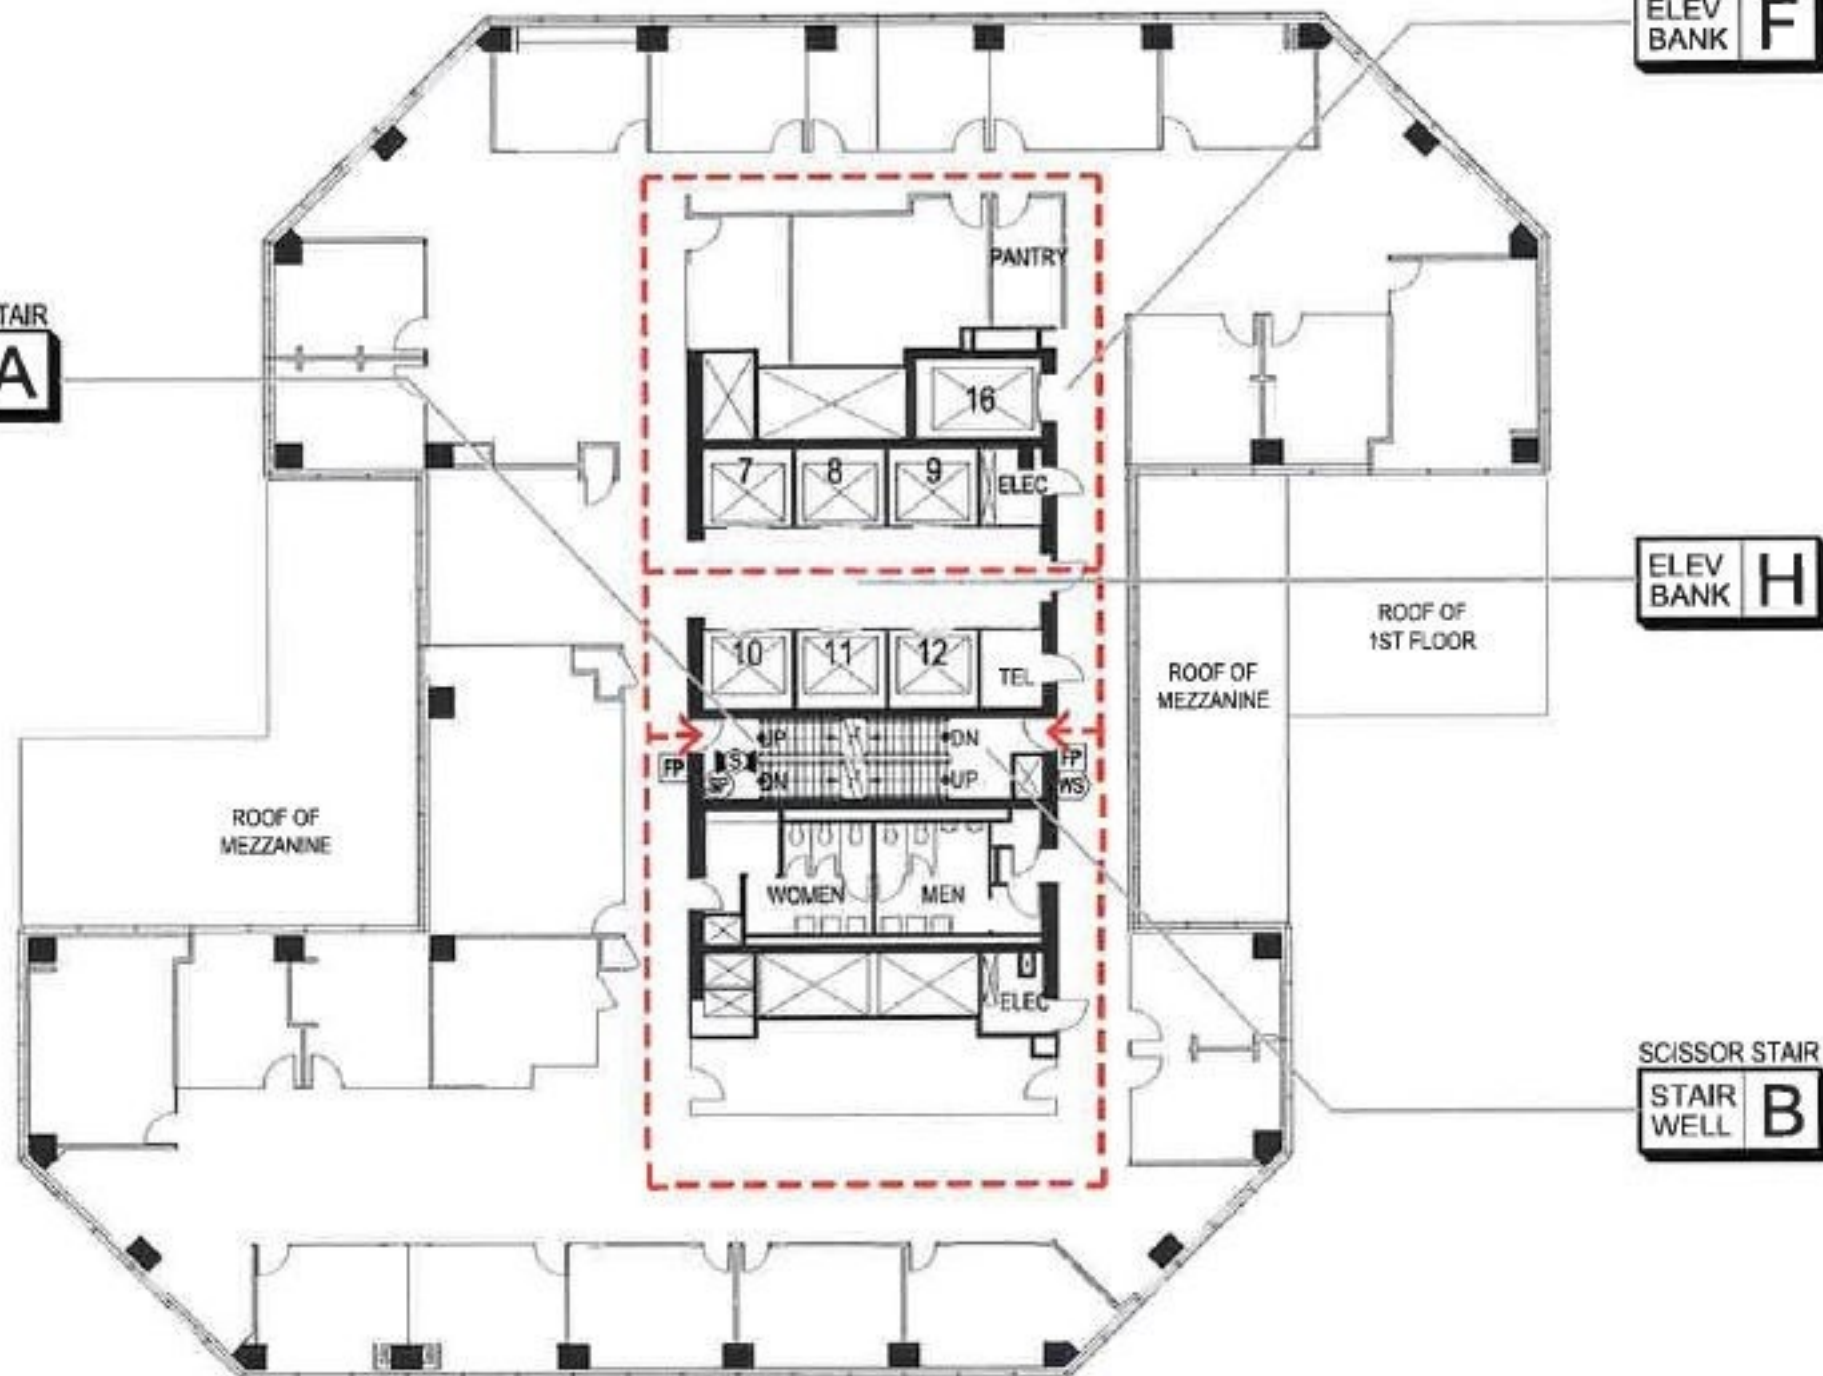

ELEV BANK F

ELEV BANK H

SCISSOR STAIR
STAIR WELL B

East 48th Street

FULL SPRINKLER COVERAGE



LEGEND

- FP Fire-Alarm Pull
- SP Standpipe Outlet (with hose valve)
- WS Warden Station (Fire phone or phone jack)
- FCS Fire Command Station (See 1st Floor)
- Y Fire Dept. Connection (See 1st Floor & Site Plan)
- SV Sprinkler Valve (SV)
- CV Combo. Valve (CV)
- DWV Domestic Water Valve

EXIT — Evacuation Route

Furniture / Equip. (removable equipment/ removable partitions)

Permanent Partition (non-removable permanent partitions)

Fire Barrier (fire rated enclosures that are fire stopped; ex: permanent partition, walls of demising, corridors, & mech. equip. rooms)

In-Building Relocation Areas (IBRAs)

Non-Sprinkled Areas (shows on floor with partial sprinkler coverage)

NO.	DATE	NAME	REVISION/DESCRIPTION
1	07/08/17	K.M.	REVISION: REVISED FOR SPRINKLER
2	11/01/17	K.M.	REVISED PER CREDIT COMMENTS

Drawn By: J.G. / K.M. Checked By: J.G.

BUILDING ADDRESS:
12 East 49th St
New York, NY 10017
AKA TOWER 49

DRAWING TITLE:
FL-30
30th Floor

SURVEY BY: K.M. SURVEY DATE(S): 08.09-11.17