


1 5th FLOOR ARCHITECTURAL POWER & VOICE/DATA PLAN  
SCALE: 1/8" = 1'-0"

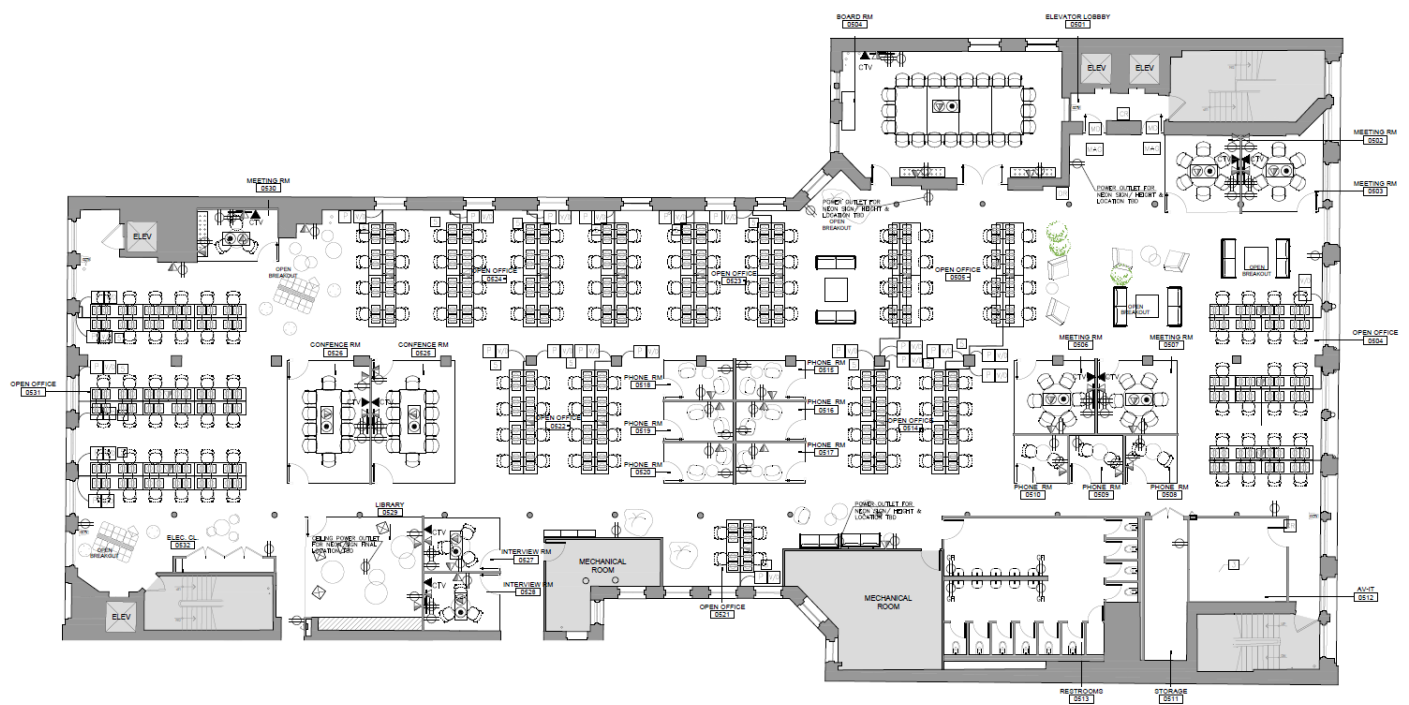

1 5th FLOOR ARCHITECTURAL POWER & VOICE/DATA PLAN  
SCALE: 1/8" = 1'-0"

