


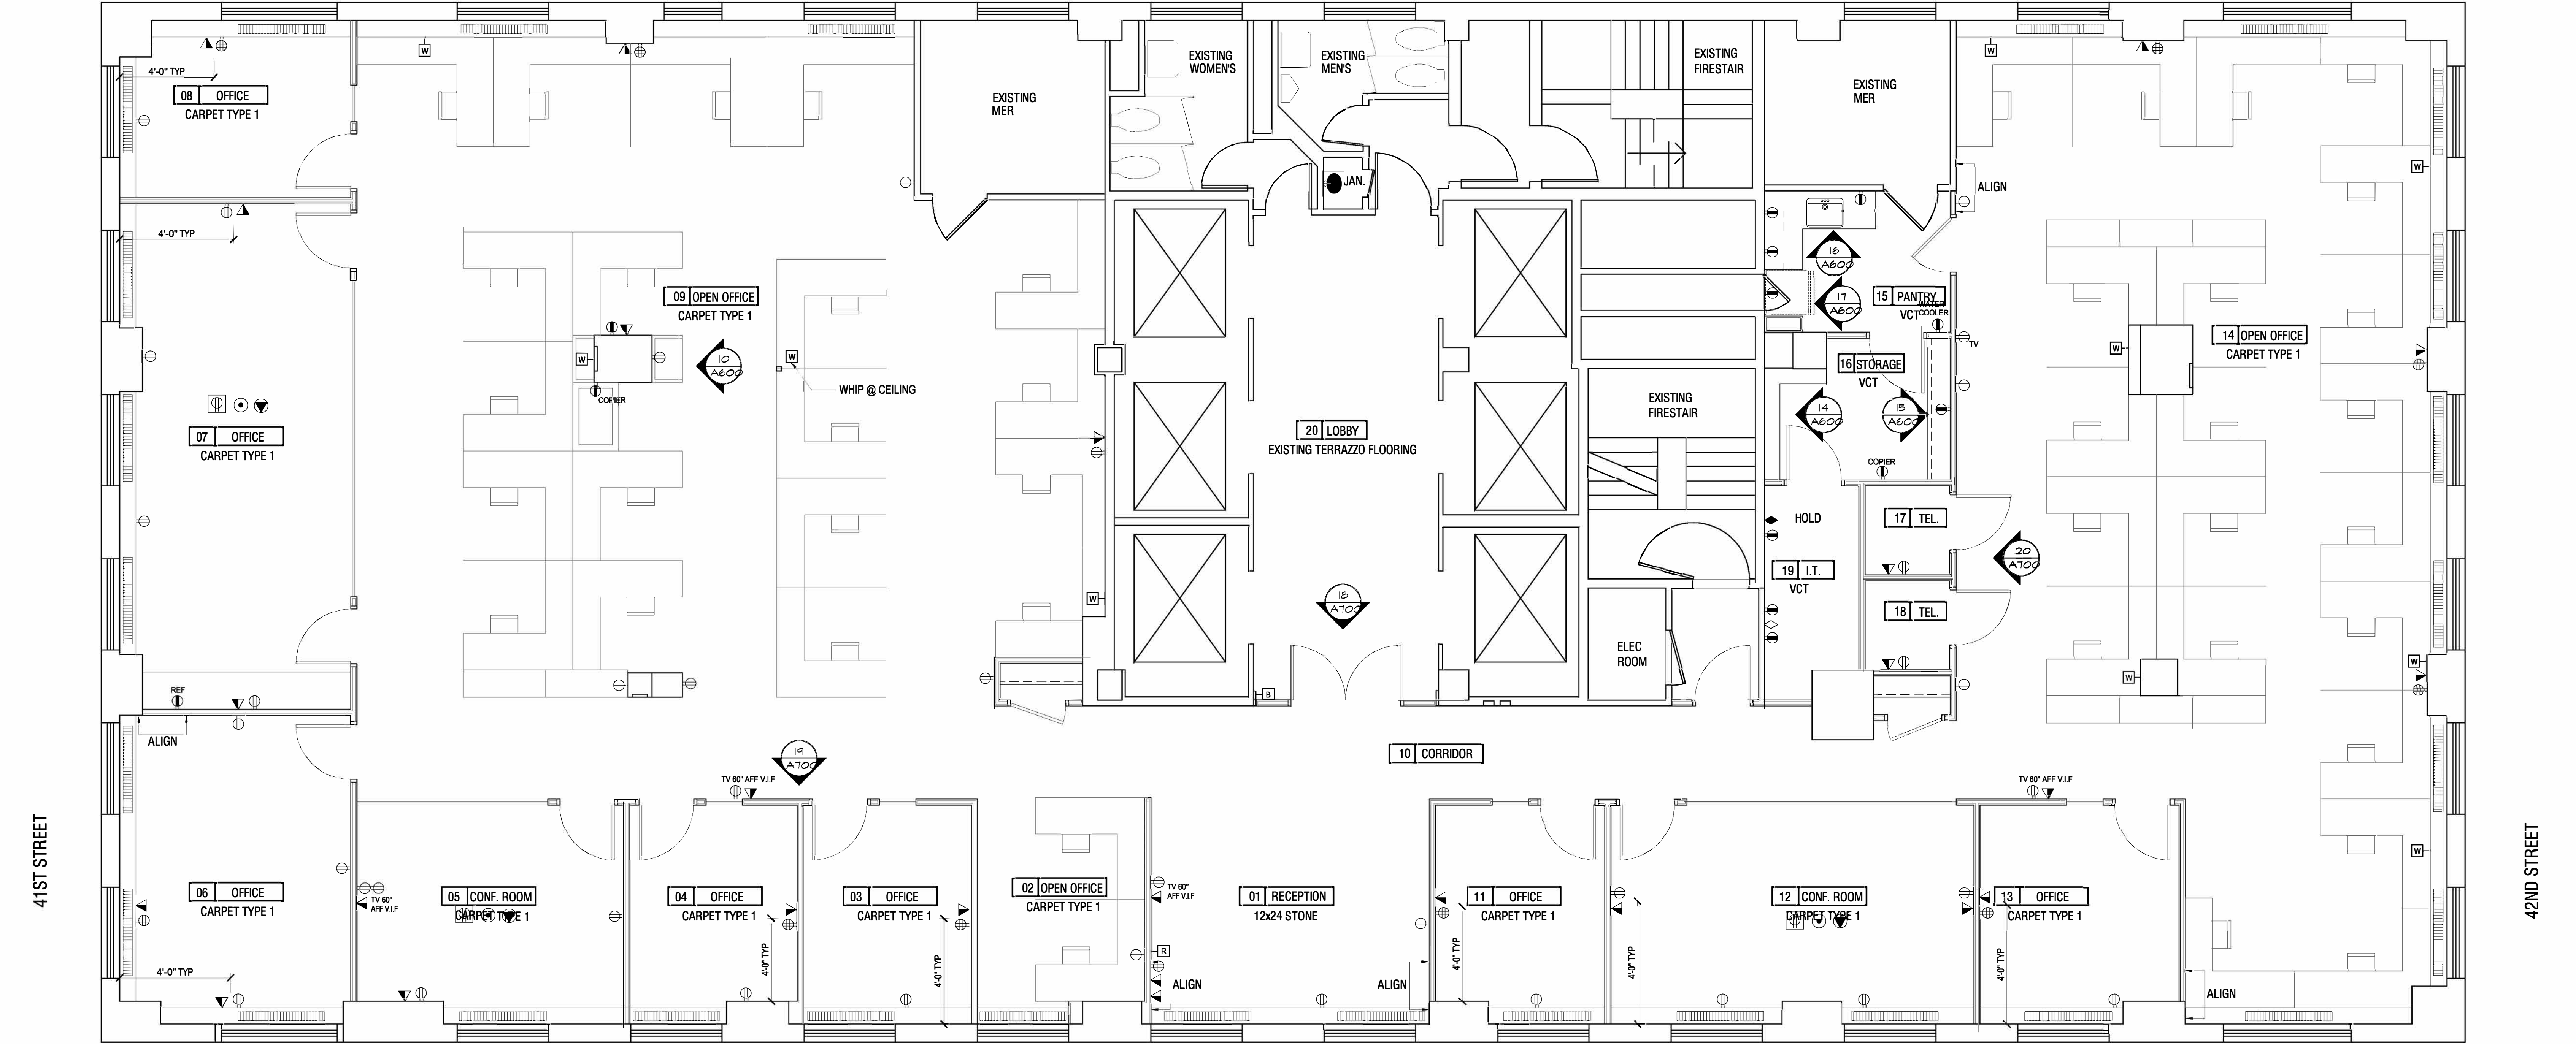

1

34TH FLOOR POWER AND COMMUNICATIONS PLAN

SCALE: 1/4" = 1'-0"

N

⊕

DUPLEX RECEPTACLE WALL MOUNTED @ 15" AFF, U.O.N., 120V

⊕GFI

DUPLEX RECEPTACLE, GROUND FAULT CIRCUIT INTERRUPTER, @ 42" AFF, U.O.N., 120V

⊕

SEPARATE CIRCUIT

⊕

QUAD RECEPTACLE WALL MOUNTED @ 15" AFF, U.O.N., 120V

W

ELECTRICAL WHIP FOR ELECTRIFIED FURNITURE W/ 2 DATA/TEL DROPS

▽

DATA/TELEPHONE RECEPTACLE, @ 15" AFF, U.O.N.

—C

CABLE TELEVISION JACK VERIFY HEIGHT IN FIELD WITH ARCHITECT

—B

DOOR BUZZER

—R

DOOR RELEASE

◆

TELEPHONE HUB

◇

DATA HUB

⊕

DUPLEX RECEPTACLE FOR AV EQUIPMENT ABOVE CEILING

●

FLOOR OUTLET

▼

FLOOR OUTLET DATA/TEL

THE CHANIN BUILDING

122 EAST 42ND STREET, NEW YORK, NEW YORK 10168

FLOOR 34

ISSUED: December 12th, 2012

A-500.00